

- NOTES:
1. THIS DESIGN & DRAWING ARE COPYRIGHT UNDER D'CAZ MEDIA RESOURCE KL& NO PART OF IT CAN BE COPIED OR REPRODUCED IN ANY FORM WITHOUT THE WRITTEN CONSENT FROM THE COMPANY.
 2. ALL DIMENSIONS ARE AS SHOWN BUT FINAL ADJUSTMENT IS TO BE MADE TO SUIT EXISTING SITE CONDITIONS AND CONSTRAINTS. NO DRAWING IS TO BE SCALED OFF.
 3. SOFT LANDSCAPE OR LOOSE FURNITURE AND ACCESSORIES UNLESS EXPLICITLY DETAILED IN THE BQ OR QUOTATION SHALL NOT FORM A PART OF THIS CONTRACT.

REV	AMENDMENT	DD/MM/YY

PROJECT:
TEO SOON

CLIENT: TEO SOON

TITLE:
FURNITURE LAYOUT PLAN


JOB REF:

DESIGNER: KELLY

CHECK BY: WELDON

DRAWING NO: 01

SCALE: 1:100

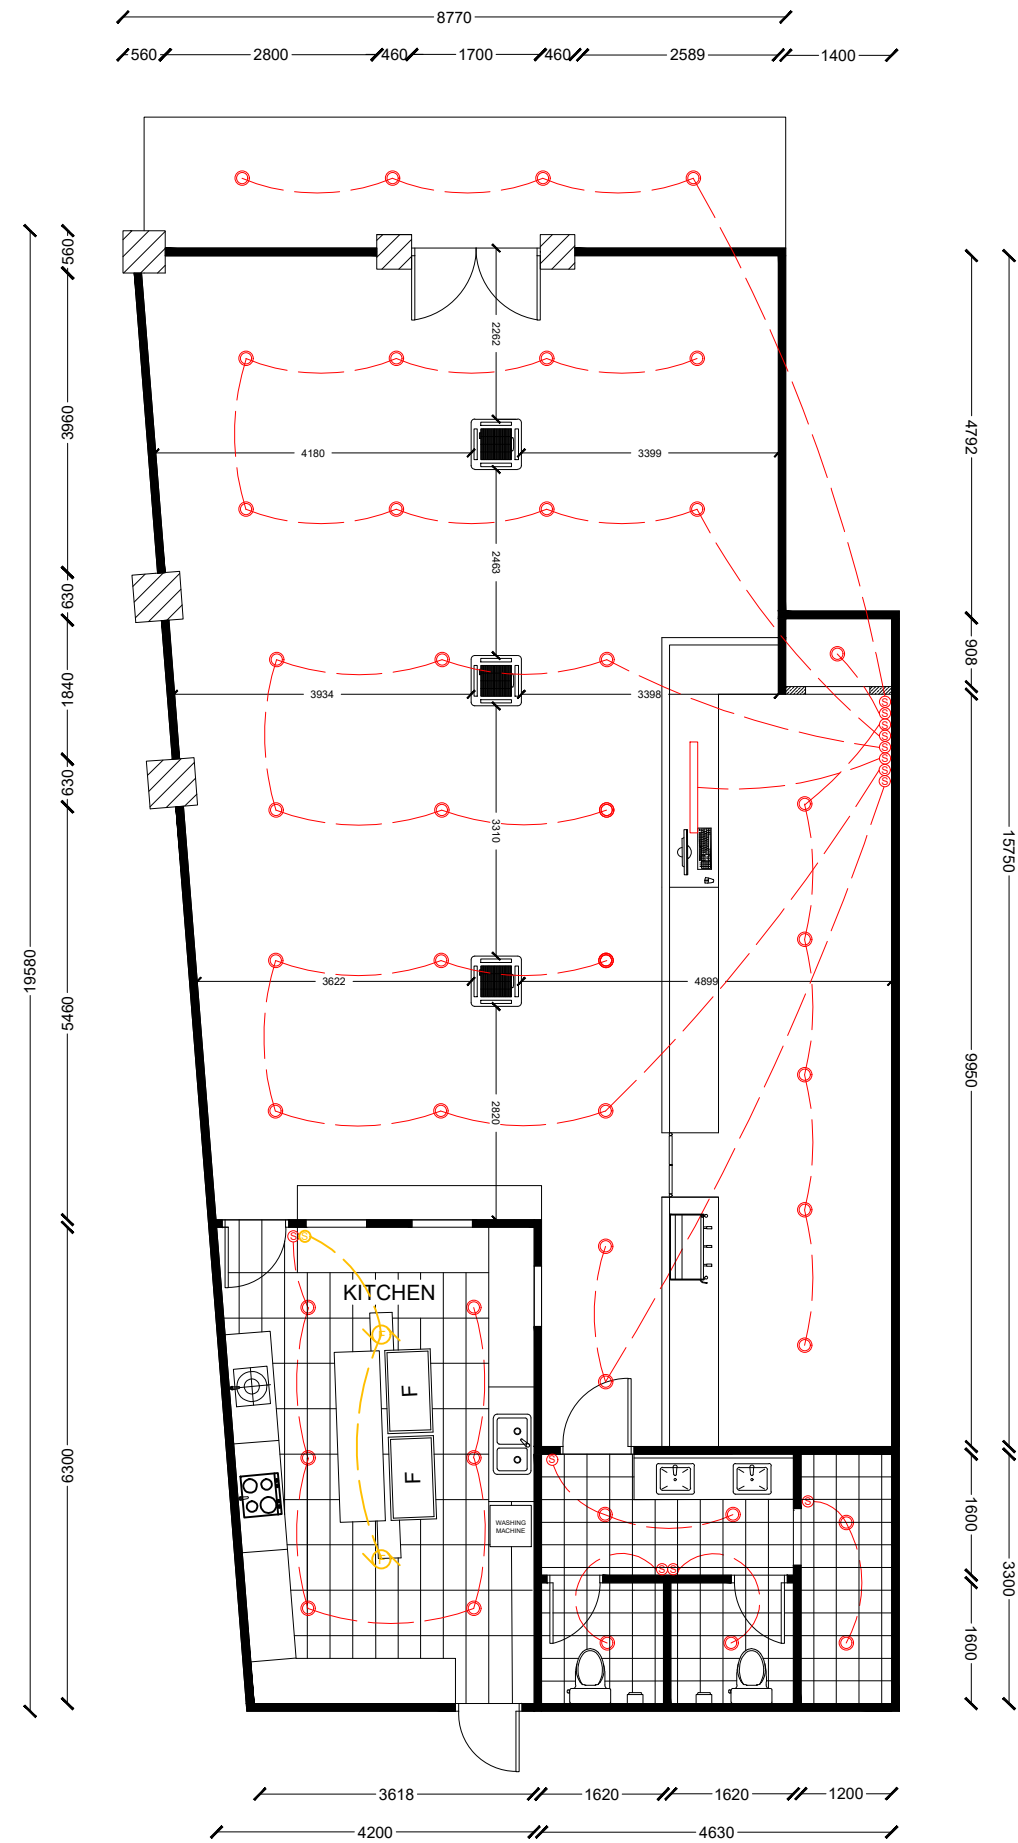

LEGEND	
	SWITCH
	DOWNLIGHT
	PENDENT LIGHT
	FAN POINT
	CASSETTE

- NOTES:
1. THIS DESIGN & DRAWING ARE COPYRIGHT UNDER D'CAZ MEDIA RESOURCE KL& NO PART OF IT CAN BE COPIED OR REPRODUCED IN ANY FORM WITHOUT THE WRITTEN CONSENT FROM THE COMPANY.
 2. ALL DIMENSIONS ARE AS SHOWN BUT FINAL ADJUSTMENT IS TO BE MADE TO SUIT EXISTING SITE CONDITIONS AND CONSTRAINTS. NO DRAWING IS TO BE SCALED OFF.
 3. SOFT LANDSCAPE OR LOOSE FURNITURE AND ACCESSORIES UNLESS EXPLICITLY DETAILED IN THE BQ OR QUOTATION SHALL NOT FORM A PART OF THIS CONTRACT.

REV	AMENDMENT	DD/MM/YY

PROJECT:
TEO SOON

CLIENT: TEO SOON

TITLE:
LIGHTING PLAN


JOB REF:

DESIGNER: KELLY

CHECK BY: WELDON

DRAWING NO: 01

SCALE: 1:100

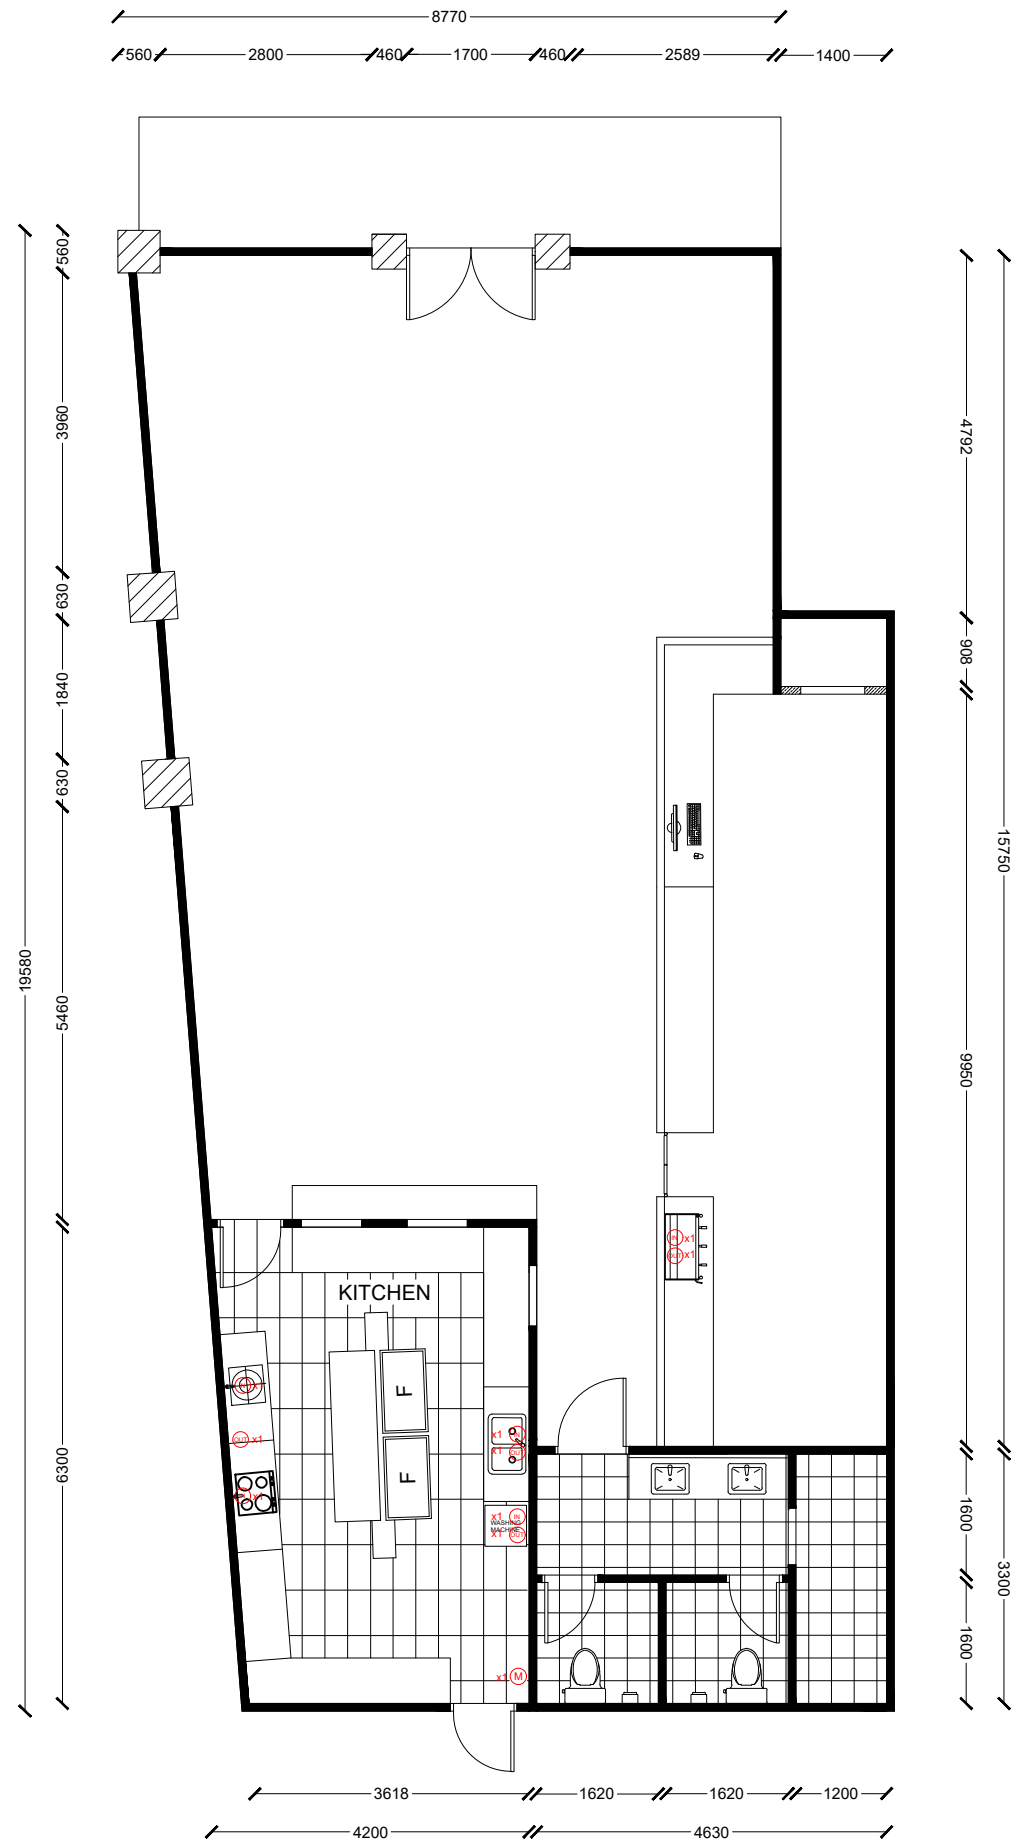

LEGEND

- (M) MAIN OUT WATER POINT
- (I) IN WATER POINT
- (O) OUT WATER POINT

NOTES:
 1. THIS DESIGN & DRAWING ARE COPYRIGHT UNDER D'CAZ MEDIA RESOURCE KL& NO PART OF IT CAN BE COPIED OR REPRODUCED IN ANY FORM WITHOUT THE WRITTEN CONSENT FROM THE COMPANY.
 2. ALL DIMENSIONS ARE AS SHOWN BUT FINAL ADJUSTMENT IS TO BE MADE TO SUIT EXISTING SITE CONDITIONS AND CONSTRAINTS. NO DRAWING IS TO BE SCALED OFF.
 3. SOFT LANDSCAPE OR LOOSE FURNITURE AND ACCESSORIES UNLESS EXPLICITLY DETAILED IN THE BQ OR QUOTATION SHALL NOT FORM A PART OF THIS CONTRACT.

REV	AMENDMENT	DD/MM/YY

PROJECT:
 TEO SOON

CLIENT: TEO SOON

TITLE:
 WATER INLET & OUTLET PLAN


JOB REF:

DESIGNER: KELLY

CHECK BY: WELDON

DRAWING NO: 01

SCALE: 1:100

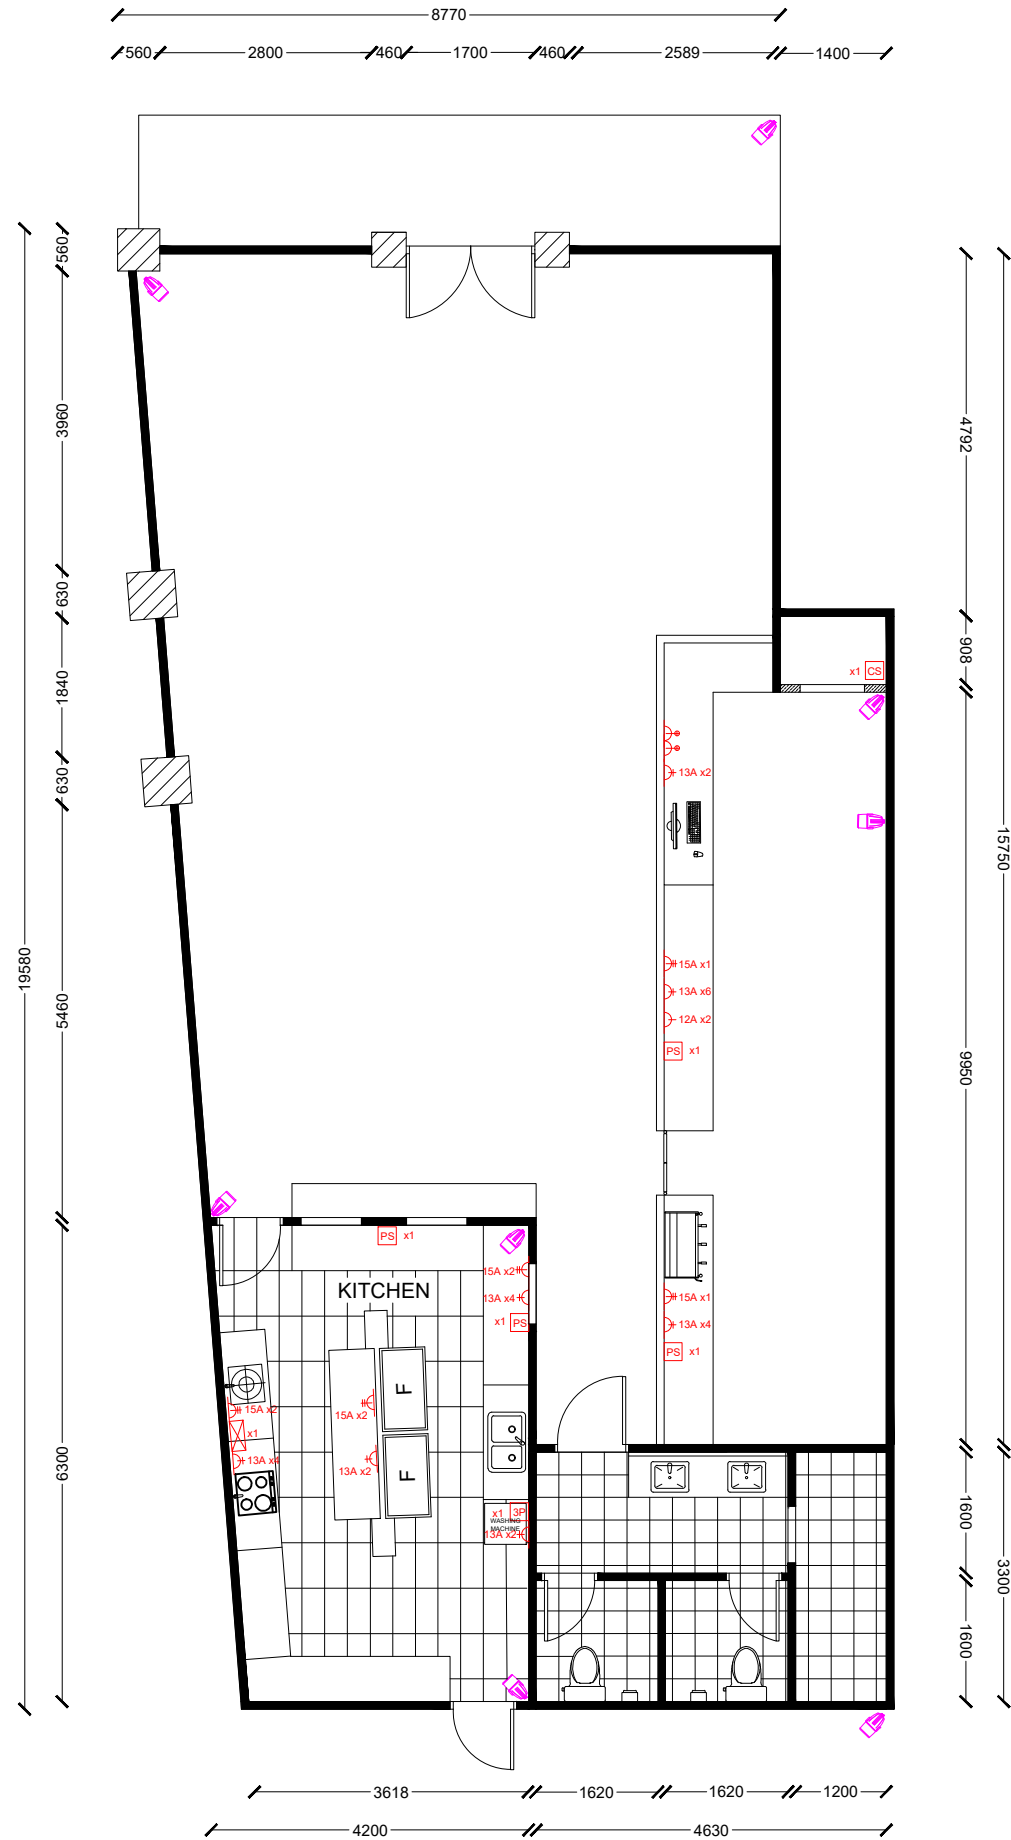

NOTES:
 1. THIS DESIGN & DRAWING ARE COPYRIGHT UNDER D'CAZ MEDIA RESOURCE KL& NO PART OF IT CAN BE COPIED OR REPRODUCED IN ANY FORM WITHOUT THE WRITTEN CONSENT FROM THE COMPANY.
 2. ALL DIMENSIONS ARE AS SHOWN BUT FINAL ADJUSTMENT IS TO BE MADE TO SUIT EXISTING SITE CONDITIONS AND CONSTRAINTS. NO DRAWING IS TO BE SCALED OFF.
 3. SOFT LANDSCAPE OR LOOSE FURNITURE AND ACCESSORIES UNLESS EXPLICITLY DETAILED IN THE BQ OR QUOTATION SHALL NOT FORM A PART OF THIS CONTRACT.

REV	AMENDMENT	DD/MM/YY

PROJECT:
 TEO SOON

CLIENT: TEO SOON

TITLE:
 ELECTRICAL PLAN

JOB REF:

DESIGNER: KELLY

CHECK BY: WELDON

DRAWING NO: 01

SCALE: 1:100

- LEGEND**
- CCTV
 - CCTV SYSTEM
 - 3 PHASE EXHAUST FAN
 - 12 A POWER POINT
 - 13 A POWER POINT
 - 15 A POWER POINT
 - DATA POINT
 - PRINTER SOCKET
 - 3 PHASE